


STUDIO 'A' PLAN

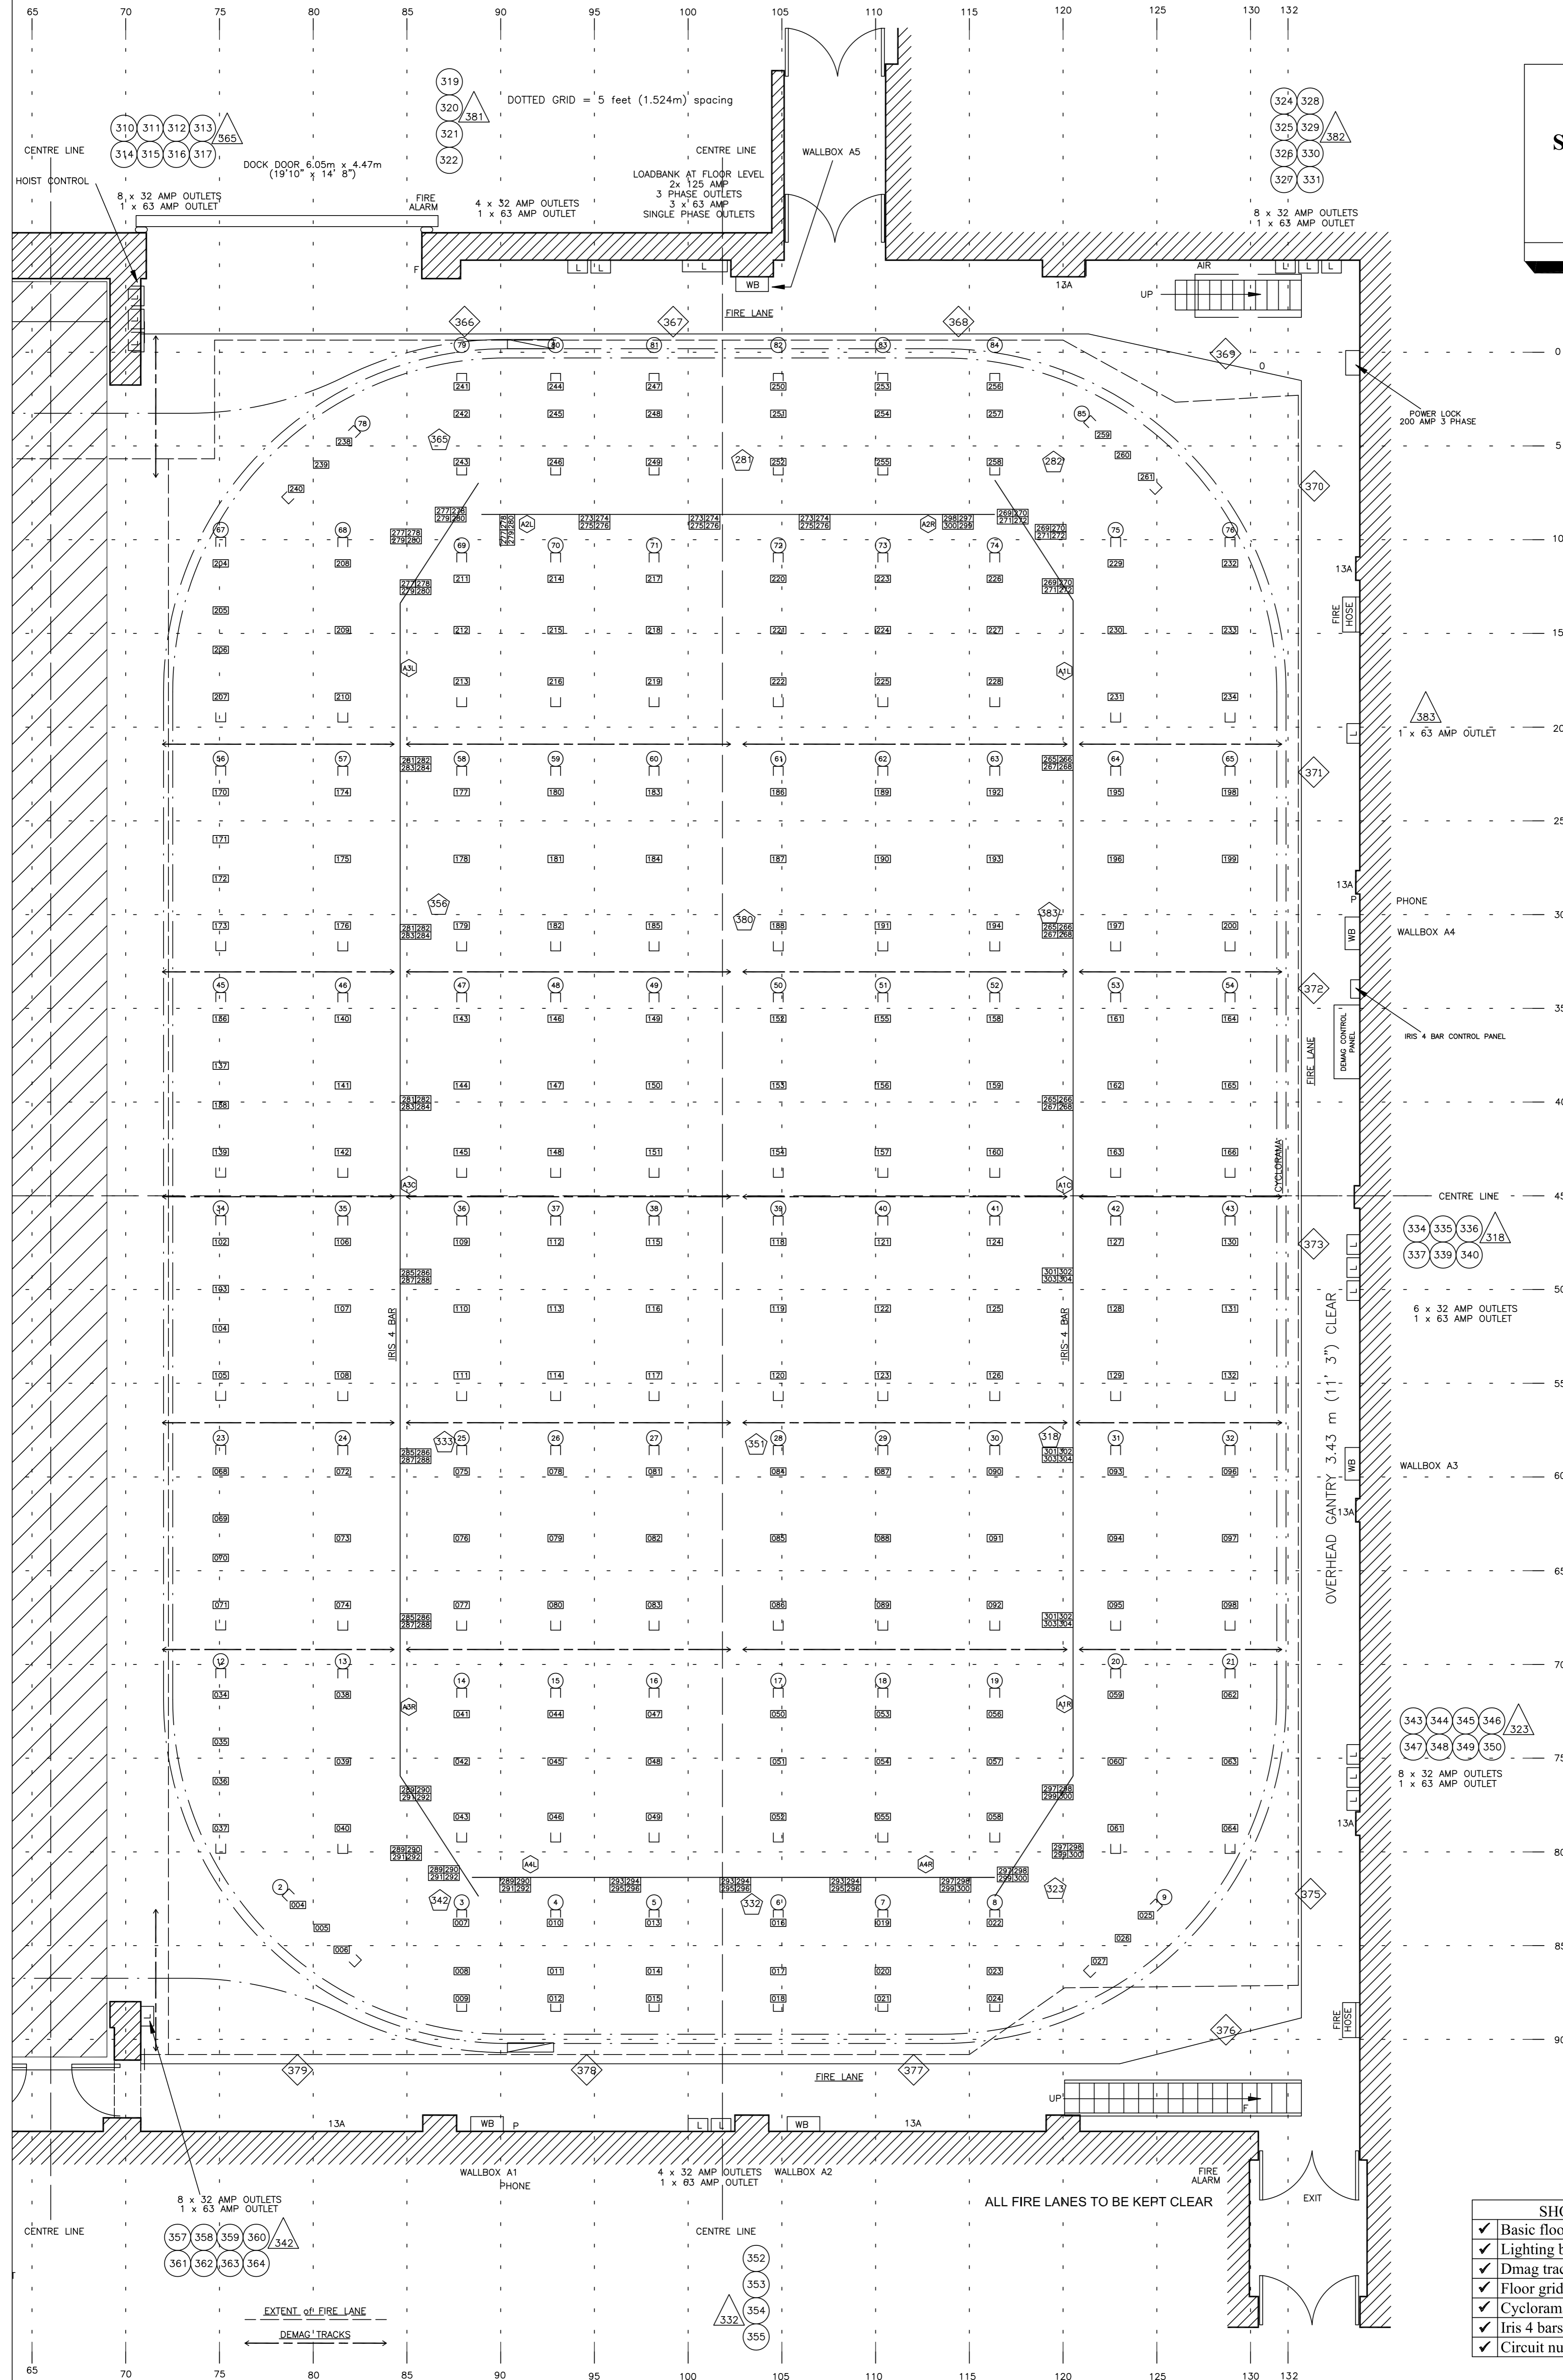

KEY TO LIGHTING CHANNELS IN IRIS 4 BAR BOXES

A1R	2271228 2271229 2271230
A1C	2251228 2251229 2251230
A1L	2271228 2271229 2271230
A2R	2281228 2281229 2281230
A2L	2271228 2271229 2271230
A3C	2281228 2281229 2281230
A3R	2251228 2251229 2251230
A4R	2281228 2281229 2281230
A4L	2251228 2251229 2251230

SHOWING	
✓	Basic floor plan + fire lanes
✓	Lighting bars
✓	Dmag tracks
✓	Floor grid
✓	Cyclorama track
✓	Iris 4 bars
✓	Circuit numbers

- 000 = CYC/LIGHTING BAR 16A CIRCUITS
- 000 = FLOOR LEVEL 32A SOCKETS
- 000 = 1 x 63A + 2 x 32A SKTS AT FLOOR LEVEL
- 000 = 63A SOCKET ON GRID WALKWAY
- 000 = LOWER WALKWAY 32A SOCKET

<p>Tel: 020 8900 5800 Fax: 020 8900 5802 http://www.fountainstudios.tv</p>	<p>TITLE: Studio A Floor Plans</p>	<p>SUBTITLE: Lighting Plot</p>	<p>DWG No. W-428</p> <p>SCALE: 1 mm = 50 mm</p> <p>Drawn By: D Green</p>
<p>ALL FIRE LANES TO BE KEPT CLEAR</p>			<p>Last Rev. 5.5 03/06/2011</p>